

SHEET LIST

A0.00	COVER SHEET
C - A1.01	CASTELAR - PLANS, ELEVATIONS
C - A1.02	CASTELAR - FINISH MATERIALS
CP - A1.01	CENTRAL PARK - PLANS, ELEVATIONS
CP - A1.02	CENTRAL PARK - FINISH MATERIALS
L - A1.01	LIBERTY - PLANS
L - A1.02	LIBERTY - ELEVATIONS
L - A1.03	LIBERTY - FINISH MATERIALS
AV0.01	AUDIO VISUAL COVER SHEET
AV1.01	CASTELAR ELEMENTARY - AUDIO VISUAL PLAN
AV1.02	CENTRAL ELEMENTARY - AUDIO VISUAL PLAN
AV1.03	LIBERTY ELEMENTARY - AUDIO VISUAL PLAN
AV2.01	AUDIO VISUAL SCHEMATIC

PROJECT LOCATIONS

CASTELAR ELEMANTARY SCHOOL 2316 S. 18TH STREET OMAHA, NE 68108
CENTRAL PARK ELEMENTARY SCHOOL 4904 N. 42ND STREET OMAHA, NE 68111
LIBERTY ELEMENTARY SCHOOL 2021 ST. MARY'S AVE OMAHA, NE 68102

TACKarchitects


2922 N. 61st Street, Studio 1
Omaha, Nebraska 68104

402-505-9778
www.tackarch.com

OPS READING RECOVERY ROOMS - PROJECT 2

Project Number: 2022.058.00
Date: 02/16/2024
Sheet Name: COVER SHEET

A0.00

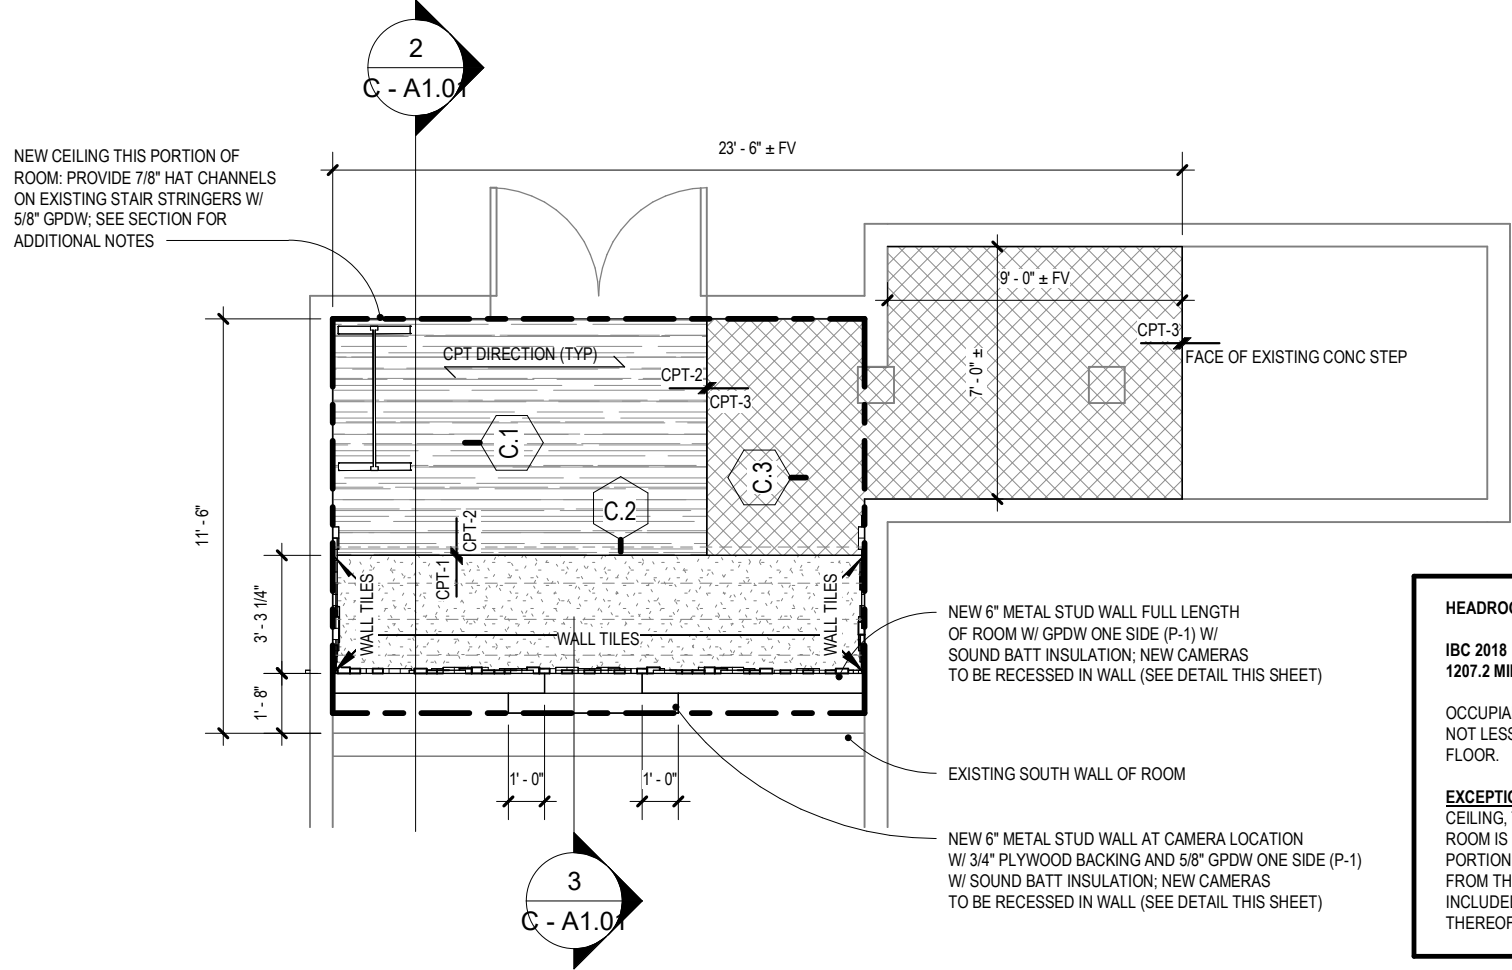


HEADROOM NOTES:

IBC 2018
1207.2 MINIMUM CEILING HEIGHTS


OCCUPIABLE SPACES SHALL HAVE A CEILING HEIGHT OF NOT LESS THAN 7 FEET 6 INCHES ABOVE THE FINISHED FLOOR.

EXCEPTION 2: IF ANY ROOM IN A BUILDING HAS A SLOPED CEILING, THE PRESCRIBED CEILING HEIGHT FOR THE ROOM IS REQUIRED IN ONE-HALF THE AREA THEREOF. ANY PORTION OF THE ROOM MEASURING LESS THAN 5 FEET FROM THE FINISHED FLOOR TO THE CEILING SHALL NOT BE INCLUDED IN ANY COMPUTATION OF THE MINIMUM AREA THEREOF.

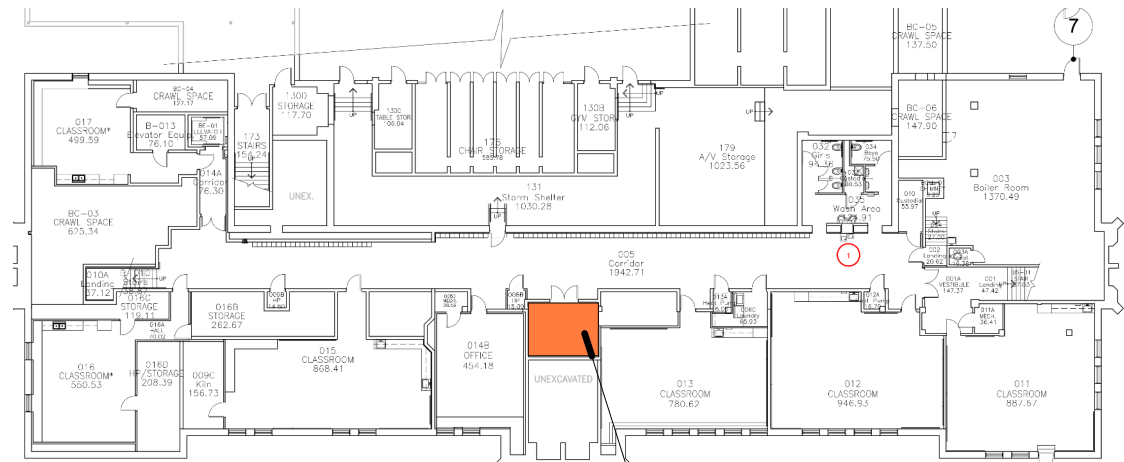


MAIN ENTRANCE
(LEVEL ABOVE)

PURPOSED READING ROOM -
BASEMENT LEVEL
(STORAGE 014)

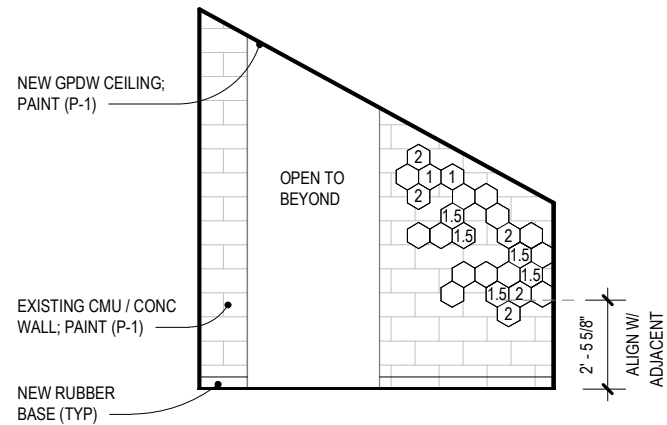


4 C.3
C - A1.01 3/16" = 1'-0"

WALL TILE QTY: 25

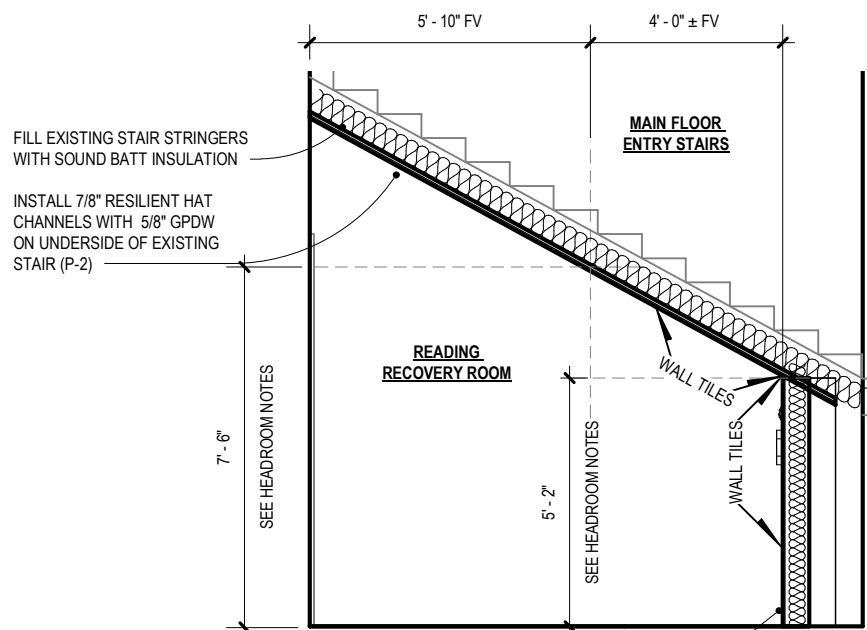


NEW 6" METAL STUD WALL W/ GPDW ONE SIDE
(P-1) W/ SOUND BATT INSULATION; NEW
CAMERAS TO BE RECESSED IN WALL
(SEE DETAIL THIS SHEET)

2 SECTION AT STAIR / NEW SLOPED CEILING
C - A1.01 1/4" = 1'-0"

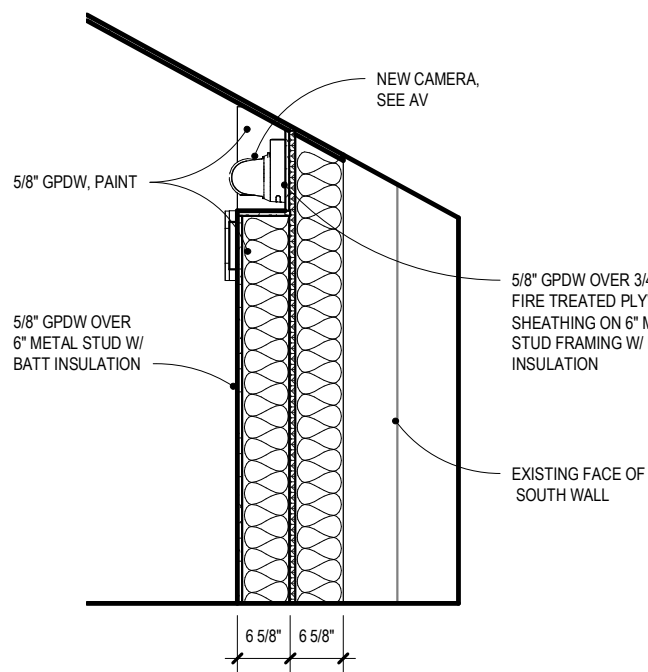


3 SECTION DETAIL AT CAMERAS
C - A1.01 1/2" = 1'-0"

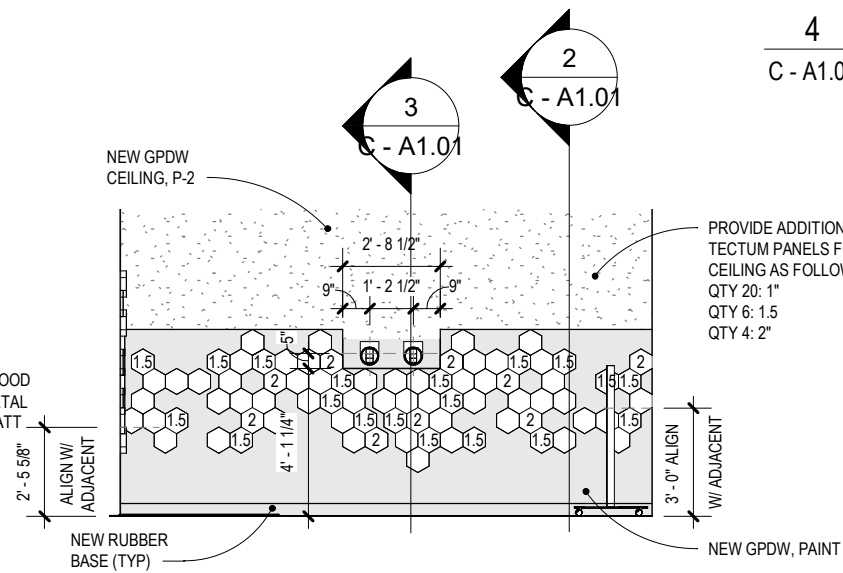

5 C.2
C - A1.01 3/16" = 1'-0"

WALL TILE QTY: 80
CEILING TILE QTY: 30

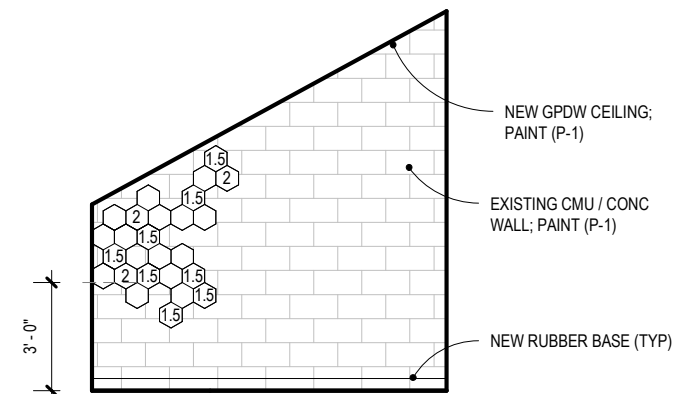

6 C.1
C - A1.01 3/16" = 1'-0"

WALL TILE QTY: 25

CASETLAR ELEMENTARY

TACKarchitects


2922 N. 61st Street, Studio 1
Omaha, Nebraska 68104

402-505-9778
www.tackarch.com

OPS READING RECOVERY ROOMS - PROJECT 2
CASTELAR ELEMENTARY

Project Number: 2022.058.00
Date: 02/16/2024
Sheet Name: CASTELAR - PLANS, ELEVATIONS

C - A1.01

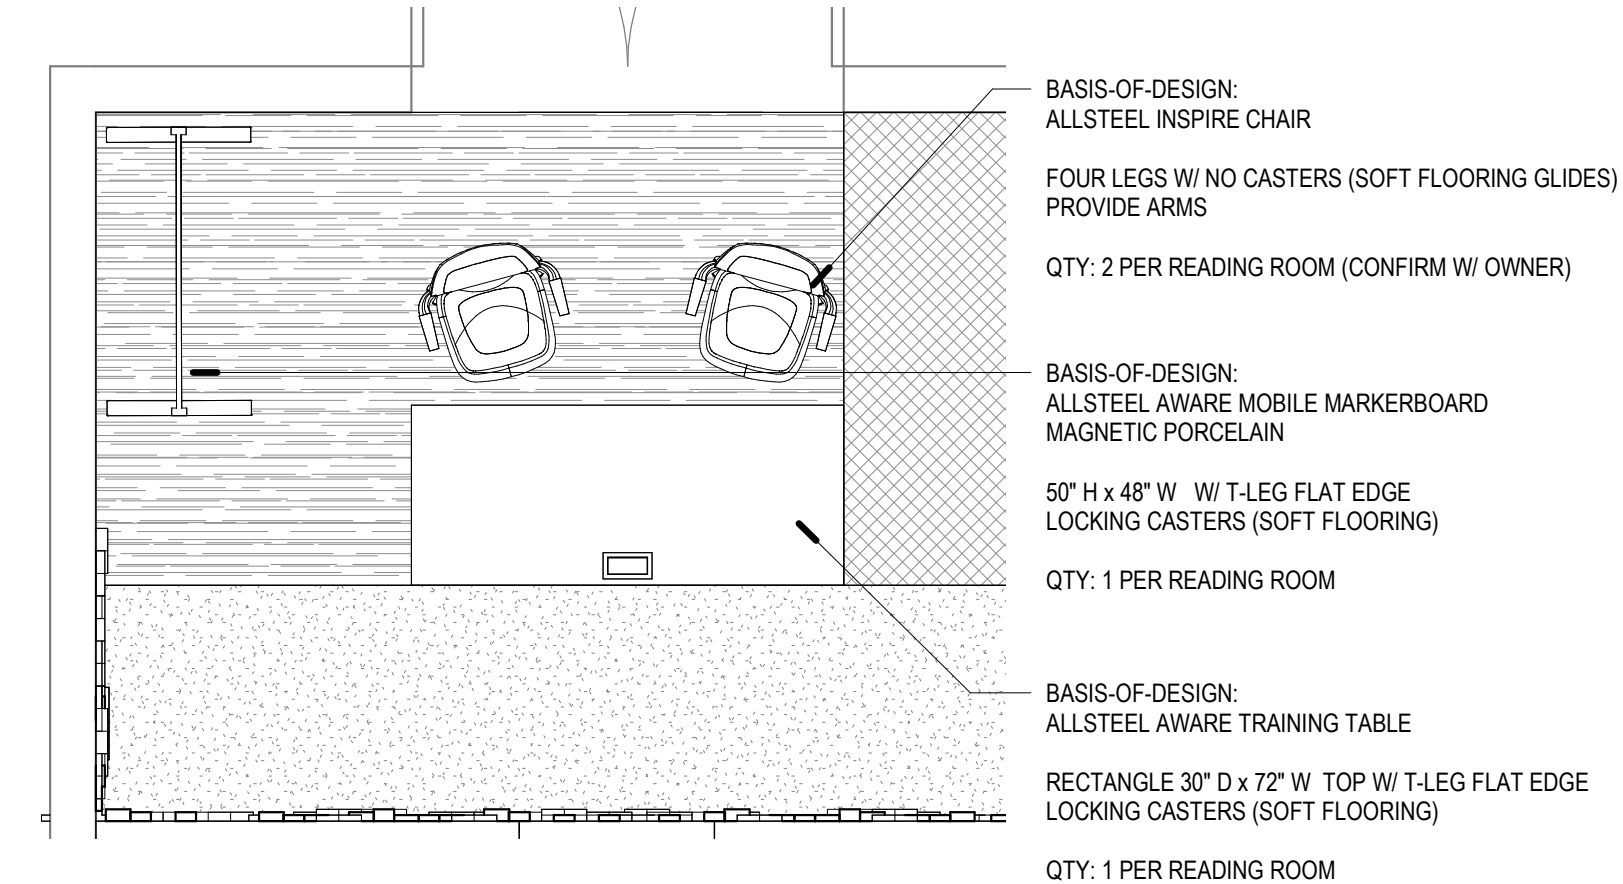

ALLSTEEL INSPIRE CHAIR
POLY SHELL COLOR: WHITE

BASE AND ARMS COLOR: CHARBLACK

ALLSTEEL AWARE TABLE

SHAPE: POLYGON
LAMINATE COLOR: FROSTY WHITE
LEG COLOR: SILVER



1 READING ROOM - TYP FURNITURE PLAN

C - A1.02 3/8" = 1'-0"

WALL TILES

- BASIS-OF-DESIGN: ARMSTRONG TECTUM PANEL ART WALLS
- SHAPE: HEXAGON
- COLOR: TO BE SELECTED BY ARCHITECT / OWNER FROM MANUFACTURER'S FULL RANGE OF CUSTOM COLORS
- SIZE: 7 1/2" X 8 11/16"
- EDGE: BEVELED (LONG SIDE) / BEVELED (SHORT SIDE)
- MOUNTING METHOD: METHOD 'A'

1 TYPE 1

- COLOR: WHITE (TWH)
- SIZE: 1"

***ALL WALL TILES TYPE 1, UNLESS
NOTED OTHERWISE

1.5 TYPE 1.5

- COLOR: YELLOW, SELECTED
FROM FULL RANGE OF
CUSTOM COLORS
- SIZE: 1.5"

2 TYPE 2

- COLOR: RED, SELECTED
FROM FULL RANGE OF
CUSTOM COLORS
- SIZE: 2"

P-1

LOCATION: ALL WALLS IN ROOM
MANUFACTURER: SHERWIN WILLIAMS
FINISH: EGG SHELL
COLOR: SW7063 NEBULOUS WHITE

P-2

LOCATION: NEW CEILING IN ROOM
MANUFACTURER: SHERWIN WILLIAMS
FINISH: FLAT
COLOR: SW7063 NEBULOUS WHITE

RB-1

LOCATION: ALL WALLS
MANUFACTURER: JOHNSONITE
STYLE: THERMOPLASTIC RUBBER, 1/8"
SIZE: 4" W/ COVE, ROLLS
COLOR: BLACK

CPT-1

MANUFACTURER: INTERFACE
STYLE: AERIAL FLYING COLOR, AE311
COLOR: 105803 MUSHROOM
SIZE: 9.845" x 39.38"
DIRECTION: ASHLAR, SEE PLAN

CPT-2

MANUFACTURER: INTERFACE
STYLE: AERIAL FLYING COLOR, AE315
COLOR: 105823 MARIGOLD
SIZE: 9.845" x 39.38"
DIRECTION: ASHLAR, SEE PLAN

CPT-3

MANUFACTURER: INTERFACE
STYLE: ON LINE
COLOR: 105269 MARIGOLD
SIZE: 9.845" x 39.38"
DIRECTION: ASHLAR, SEE PLAN

3 FINISH LEGEND

C - A1.02 3/8" = 1'-0"

2 WALL TILE LEGEND

C - A1.02 3/8" = 1'-0"

CASETLAR ELEMENTARY

TACKarchitects







2922 N. 61st Street, Studio 1
Omaha, Nebraska 68104

402-505-9778
www.tackarch.com

OPS READING RECOVERY ROOMS - PROJECT 2
CASTELAR ELEMENTARY

Project Number: 2022.058.00
Date: 02/16/2024
Sheet Name: CASTELAR - FINISH MATERIALS

C - A1.02

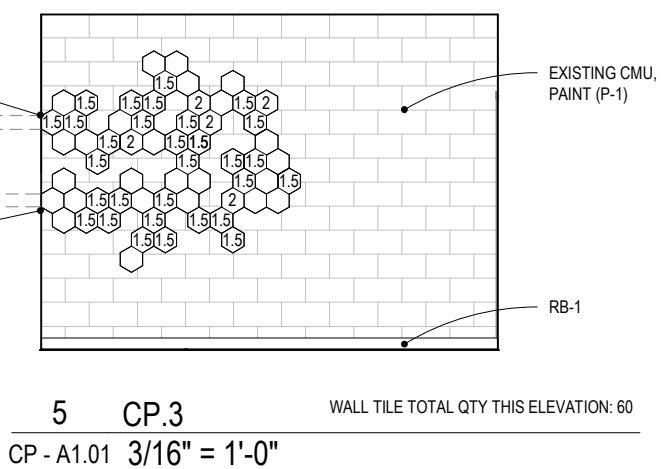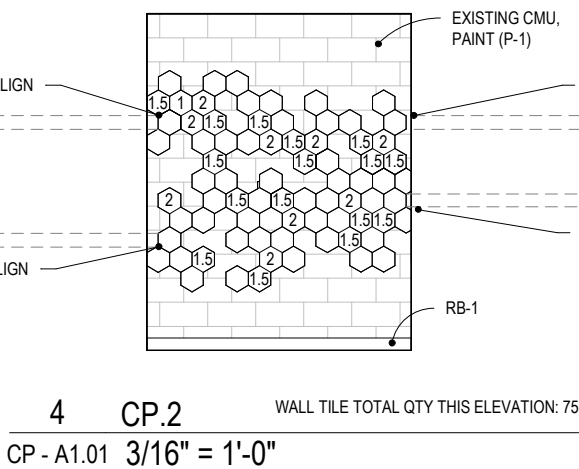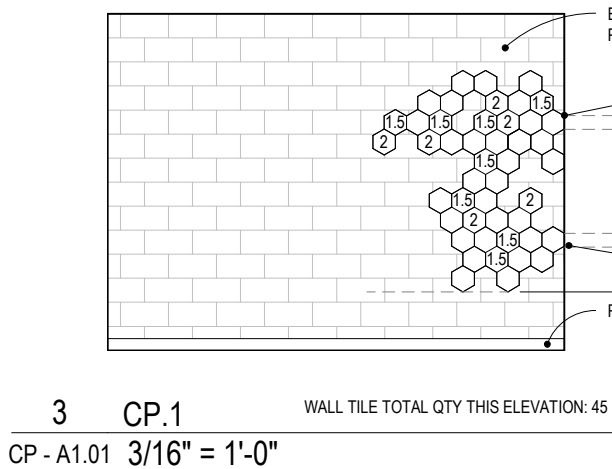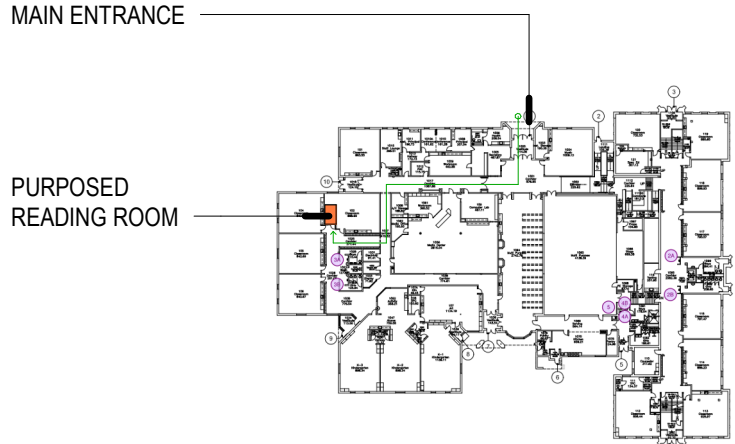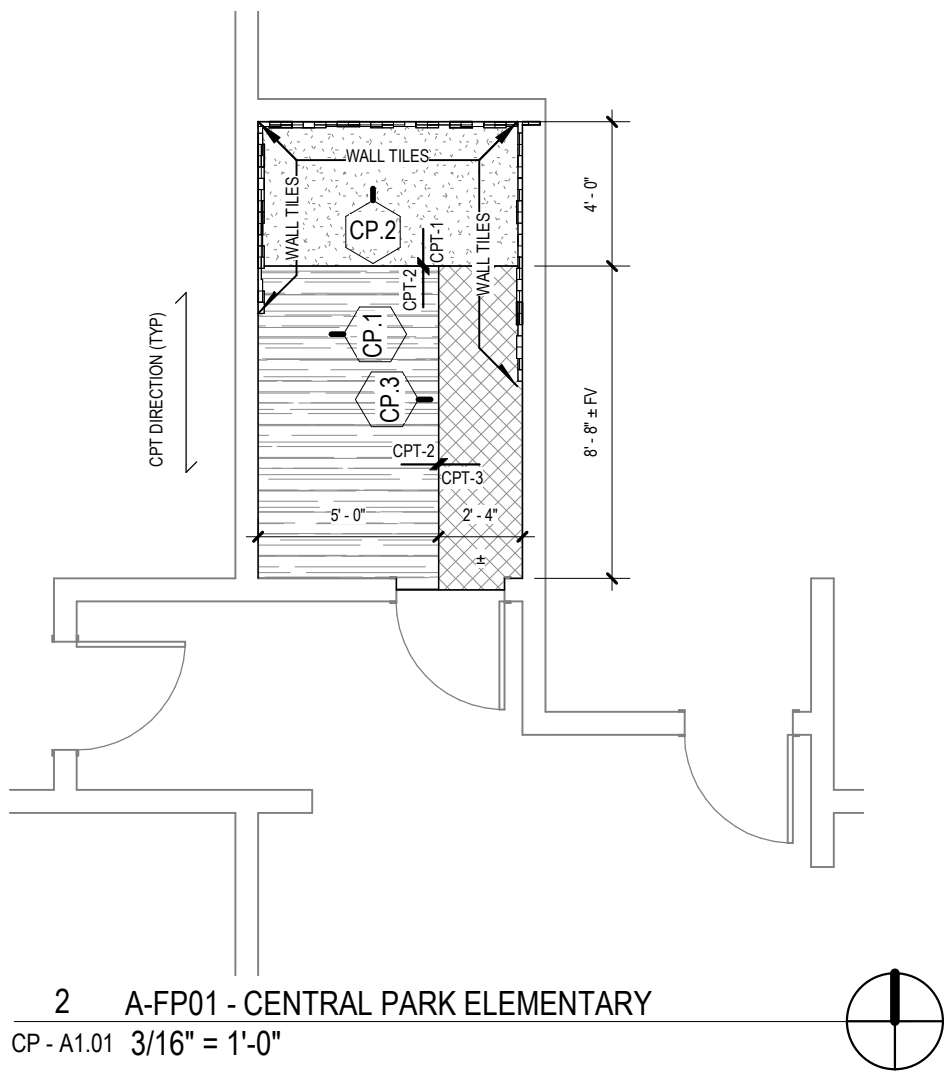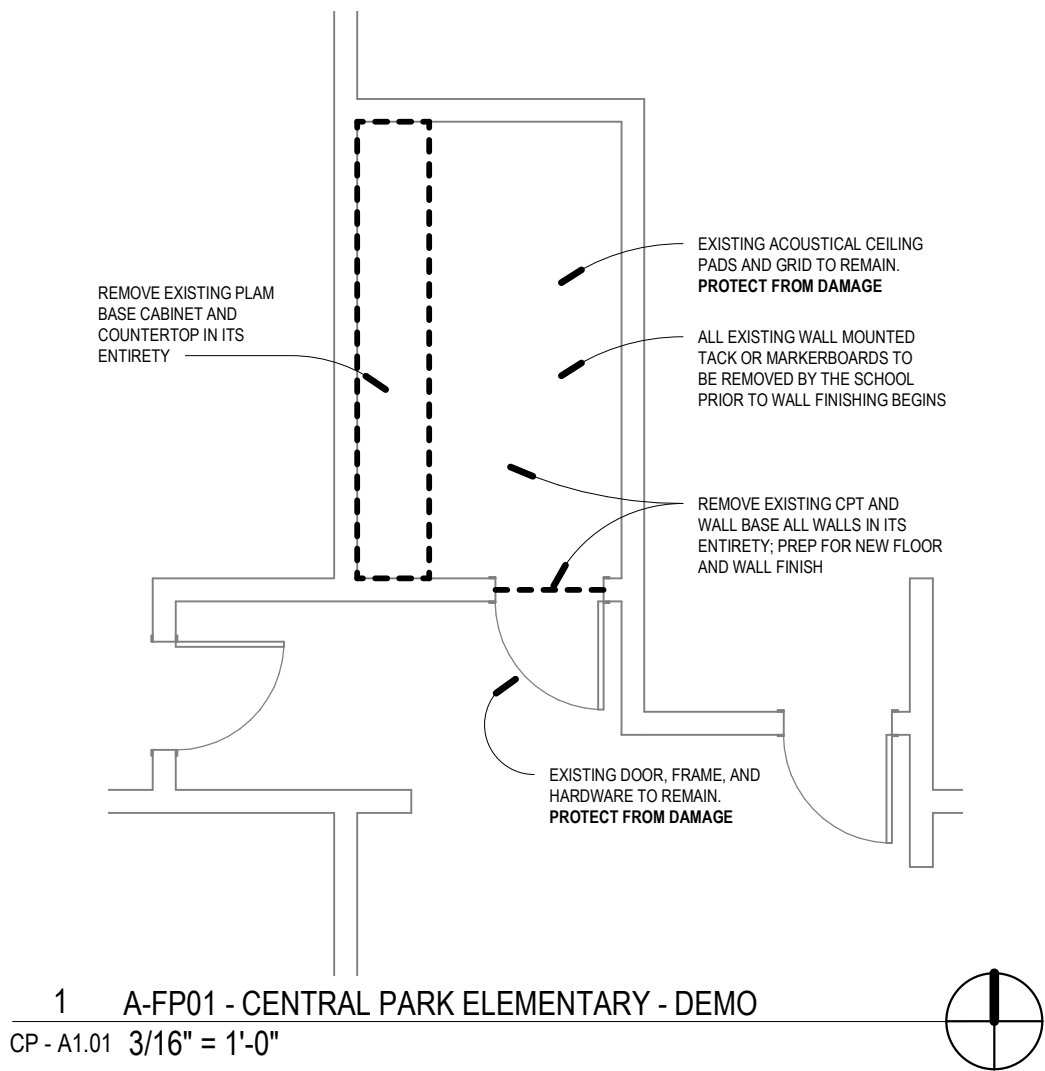


CENTRAL PARK ELEMENTARY

TACKarchitects
2922 N. 61st Street, Studio 1
Omaha, Nebraska 68104
402-505-9778
www.tackarch.com

OPS READING RECOVERY ROOMS - PROJECT 2
CENTRAL PARK ELEMENTARY

Project Number: 2022.058.00
Date: 02/16/2024
Sheet Name: CENTRAL PARK - PLANS, ELEVATIONS

CP - A1.01

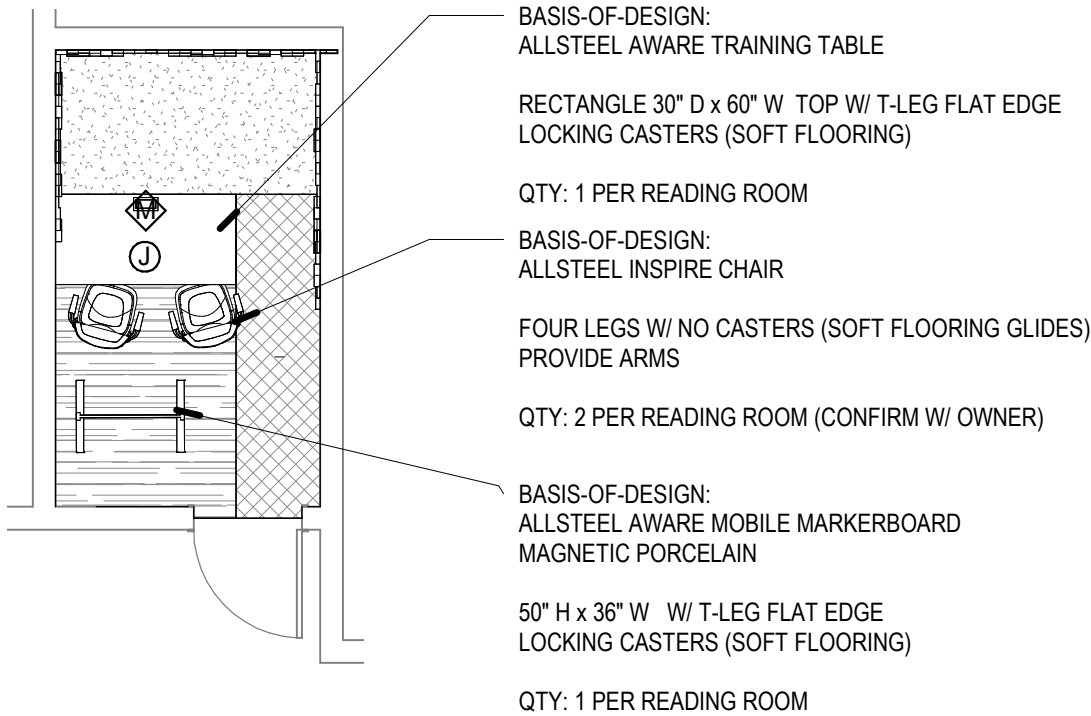

ALLSTEEL INSPIRE CHAIR
POLY SHELL COLOR: WHITE

BASE AND ARMS COLOR: CHARBLACK

NO CASTERS

ALLSTEEL AWARE TABLE

SHAPE: RECTANGLE 30" x 60"
LAMINATE COLOR: FROSTY WHITE
LEG COLOR: SILVER



1 READING ROOM - TYP FURNITURE PLAN (FURNITURE UNDER SEPERATE CONTRACT - FOR REFERENCE ONLY)
CP - A1.02 3/16" = 1'-0"

WALL TILES

- BASIS-OF-DESIGN: ARMSTRONG TECTUM PANEL ART WALLS
- SHAPE: HEXAGON
- COLOR: TO BE SELECTED BY ARCHITECT / OWNER FROM MANUFACTURER'S FULL RANGE OF CUSTOM COLORS
- SIZE: 7 1/2" X 8 11/16"
- EDGE: BEVELED (LONG SIDE) / BEVELED (SHORT SIDE)
- MOUNTING METHOD: METHOD 'A'

1 TYPE 1

- COLOR: WHITE (TWH)
- SIZE: 1"

***ALL WALL TILES TYPE 1, UNLESS NOTED OTHERWISE

1.5 TYPE 1.5

- COLOR: SELECTED FROM FULL RANGE (50% OF THIS TYPE TO MATCH CPT-1; 50% OF THIS TYPE TO MATCH CPT-3)
- SIZE: 1.5"

2 TYPE 2

- COLOR: SELECTED FROM FULL RANGE (COLOR TO MATCH SCHOOL BRAND YELLOW)
- SIZE: 2"

P-1

LOCATION: ALL WALLS
MANUFACTURER: SHERWIN WILLIAMS
FINISH: EGG SHELL
COLOR: SW7063 NEBULOUS WHITE

RB-1

LOCATION: ALL WALLS
MANUFACTURER: JOHNSONITE
STYLE: THERMOPLASTIC RUBBER, 1/8"
SIZE: 4" W/ COVE, ROLLS
COLOR: BLACK

CPT-1

MANUFACTURER: INTERFACE
STYLE: AERIAL FLYING COLOR, AE311
COLOR: 105805 GRANITE
SIZE: 9.845" x 39.38"
DIRECTION: ASHLAR, SEE PLAN

CPT-2


MANUFACTURER: INTERFACE
STYLE: AERIAL FLYING COLOR, AE315
COLOR: 105816 GRANITE / AZURE
SIZE: 9.845" x 39.38"
DIRECTION: ASHLAR, SEE PLAN

CPT-3


MANUFACTURER: INTERFACE
STYLE: AERIAL FLYING COLOR
COLOR: 105829 AZURE
SIZE: 9.845" x 39.38"
DIRECTION: ASHLAR, SEE PLAN

2 WALL TILE LEGEND
CP - A1.02 3/8" = 1'-0"


3 FINISH LEGEND
CP - A1.02 3/8" = 1'-0"

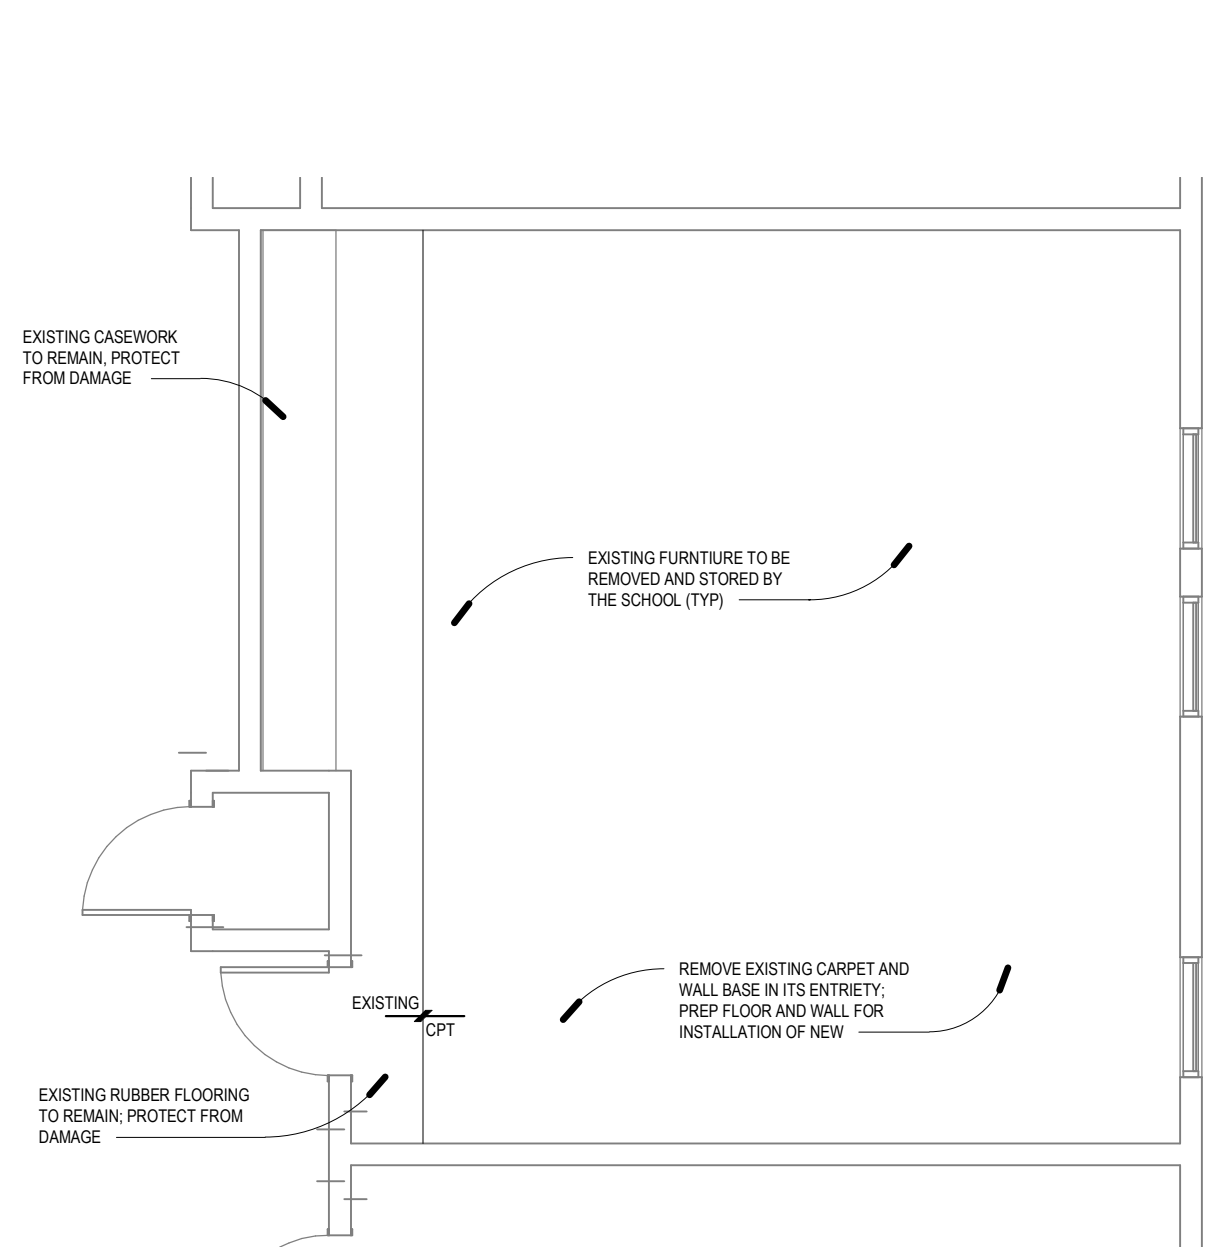

1 A-FP01 - LIBERTY ELEMENTARY - DEMO
L - A1.01 3/16" = 1'-0"

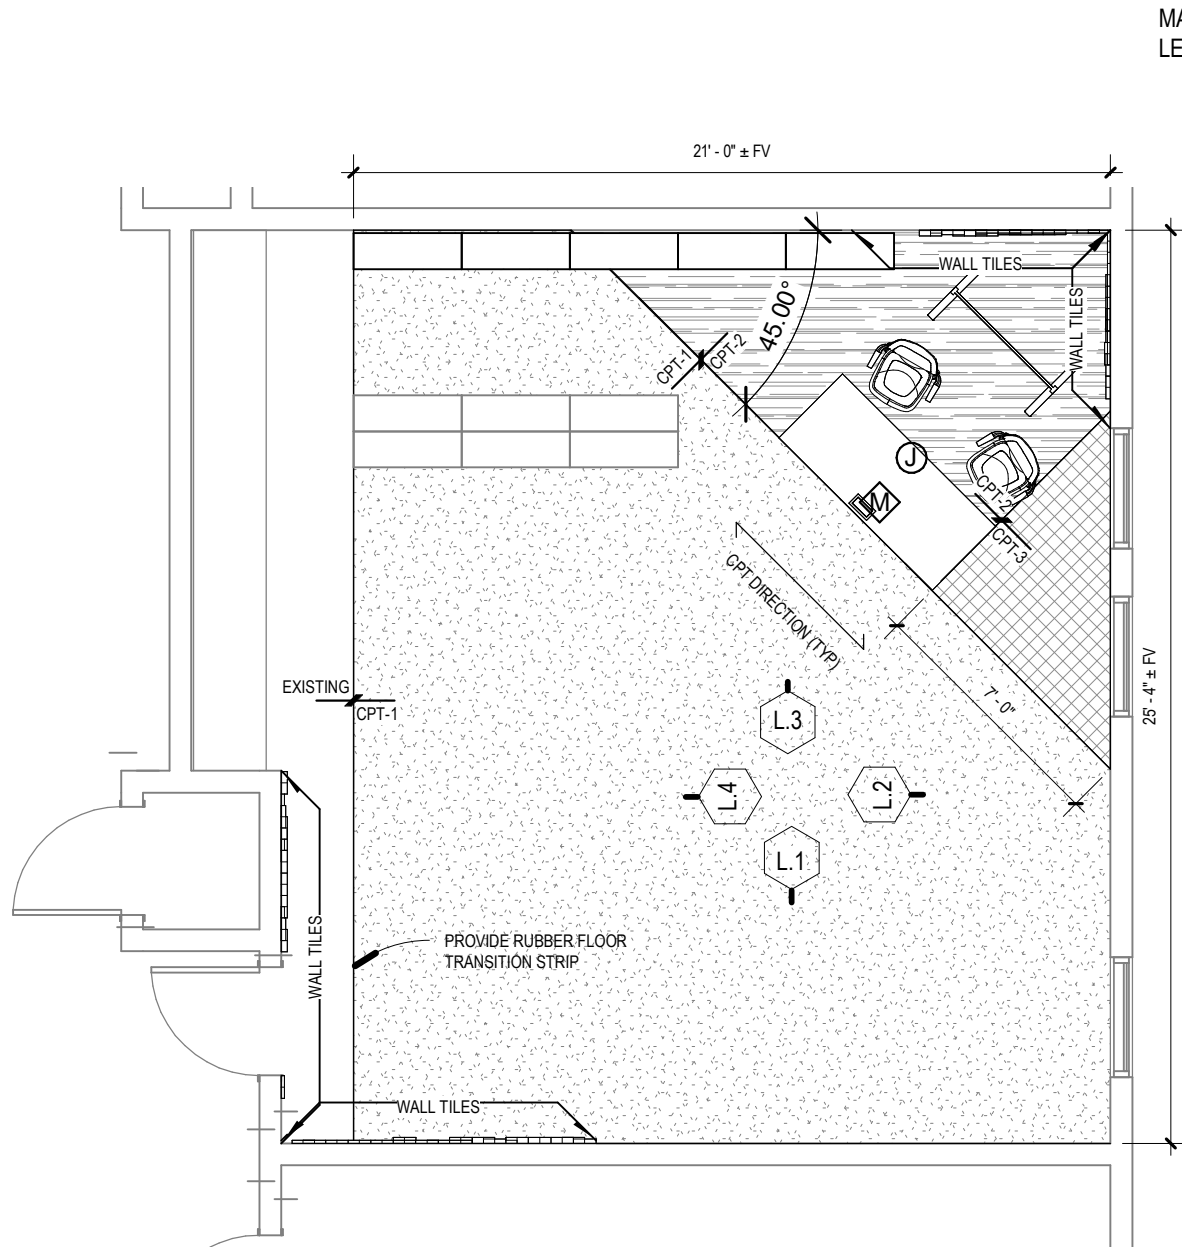

2 A-FP01 - LIBERTY ELEMENTARY
L - A1.01 3/16" = 1'-0"

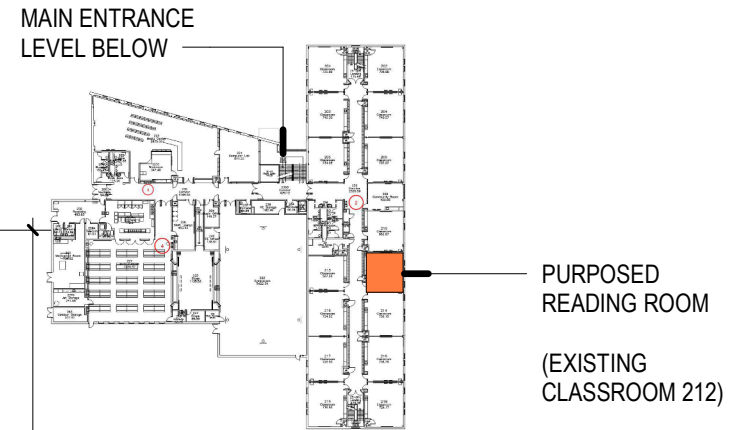

LIBERTY ELEMENTARY


TACKarchitects
2922 N. 61st Street, Studio 1
Omaha, Nebraska 68104

402-505-9778
www.tackarch.com


OPS READING RECOVERY ROOMS - PROJECT 2
LIBERTY ELEMENTARY

Project Number: 2022.058.00
Date: 02/16/2024
Sheet Name: LIBERTY - PLANS


L - A1.01

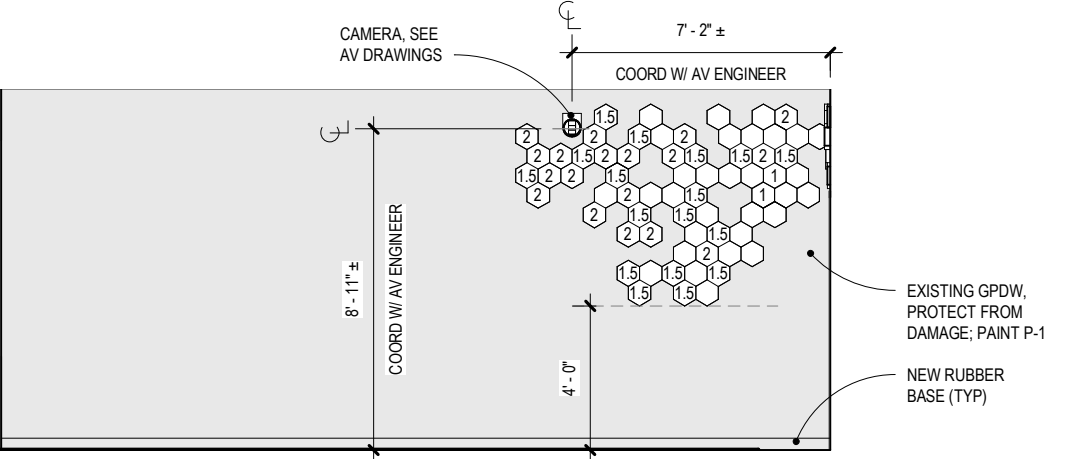


1 L.1 - SOUTH ELEVATION
L - A1.02 3/16" = 1'-0" WALL TILE TOTAL QTY THIS ELEVATION: 80

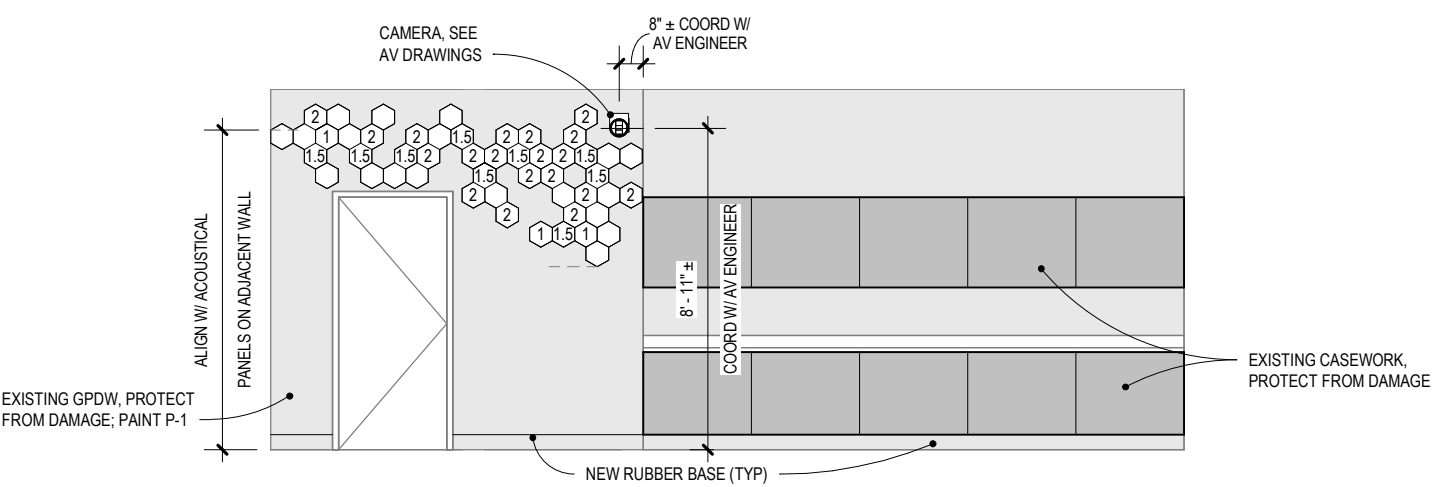


4 L.4 - WEST ELEVATION
L - A1.02 3/16" = 1'-0" WALL TILE TOTAL QTY THIS ELEVATION: 50

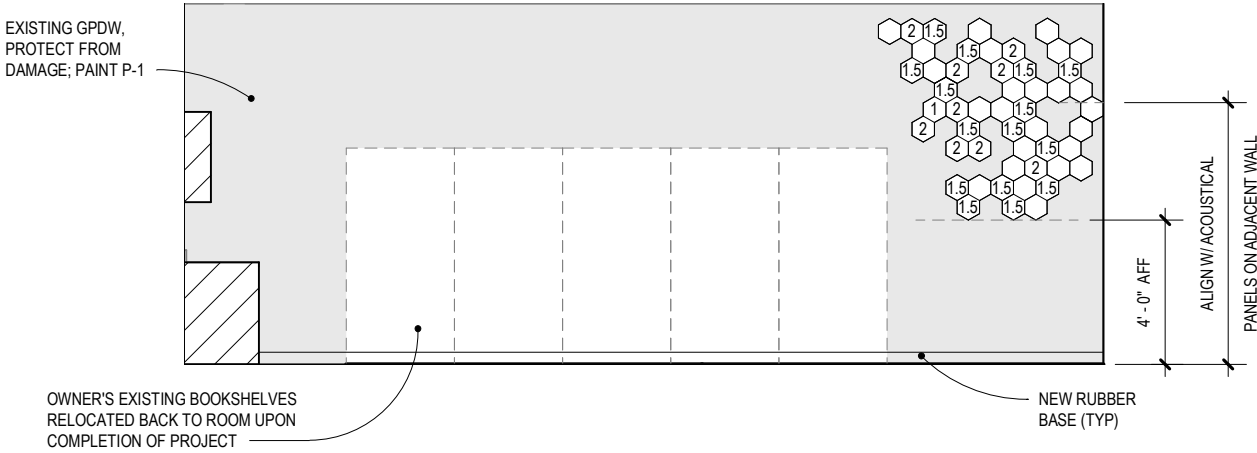

3 L.3 - NORTH ELEVATION
L - A1.02 3/16" = 1'-0" WALL TILE TOTAL QTY THIS ELEVATION: 50

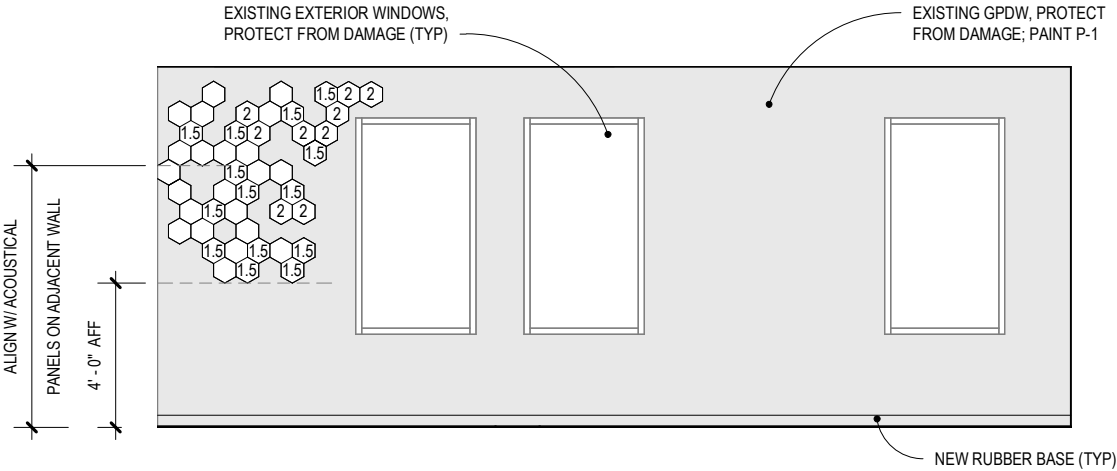

2 L.2 - EAST ELEVATION
L - A1.02 3/16" = 1'-0" WALL TILE TOTAL QTY THIS ELEVATION: 45

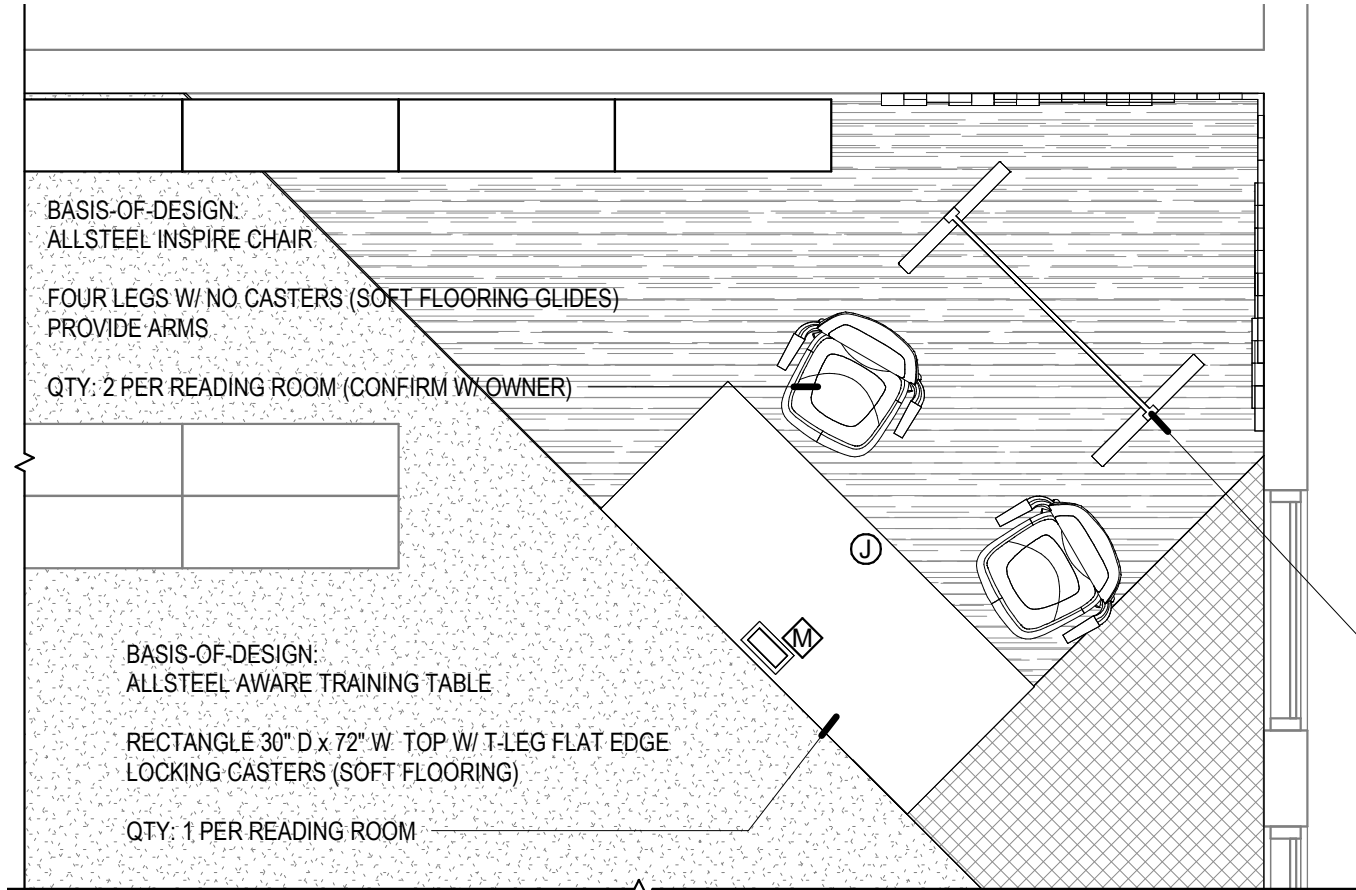

ALLSTEEL INSPIRE CHAIR
POLY SHELL COLOR: WHITE

BASE AND ARMS COLOR: CHARBLACK

ALLSTEEL AWARE TABLE

SHAPE: POLYGON
LAMINATE COLOR: FROSTY WHITE
LEG COLOR: SILVER



BASIS-OF-DESIGN:
ALLSTEEL AWARE MOBILE MARKERBOARD
MAGNETIC PORCELAIN

50" H x 48" W W/ T-LEG FLAT EDGE
LOCKING CASTERS (SOFT FLOORING)

QTY: 1 PER READING ROOM

1 READING ROOM - TYP FURNITURE PLAN (FURNITURE UNDER SEPERATE CONTRACT - FOR REFERENCE ONLY)

L - A1.03 3/8" = 1'-0"

WALL TILES

- BASIS-OF-DESIGN: ARMSTRONG TECTUM PANEL ART WALLS
- SHAPE: HEXAGON
- COLOR: TO BE SELECTED BY ARCHITECT / OWNER FROM MANUFACTURER'S FULL RANGE OF CUSTOM COLORS
- SIZE: 7 1/2" X 8 11/16"
- EDGE: BEVELED (LONG SIDE) / BEVELED (SHORT SIDE)
- MOUNTING METHOD: METHOD 'A'

1

TYPE 1

- COLOR: WHITE, MATCH P-1
- SIZE: 1"

***ALL WALL TILES TYPE 1, UNLESS NOTED OTHERWISE

1.5

TYPE 1.5

- COLOR: GRAY, SELECTED FROM FULL RANGE OF CUSTOM COLORS
- SIZE: 1.5"

2

TYPE 2

- COLOR: RED, SELECTED FROM FULL RANGE OF CUSTOM COLORS
- SIZE: 2"

P-1

LOCATION: ALL WALLS IN ROOM
MANUFACTURER: SHERWIN WILLIAMS
FINISH: EGG SHELL
COLOR: SW7063 NEBULOUS WHITE

RB-1

LOCATION: ALL WALLS AND BELOW EXISTING BASE CABINETS IN ROOM
MANUFACTURER: JOHNSONITE
STYLE: THERMOPLASTIC RUBBER, 1/8"
SIZE: 4" W/ COVE, ROLLS
COLOR: BLACK

CPT-1

MANUFACTURER: INTERFACE
STYLE: AERIAL FLYING COLOR, AE311
COLOR: 105805 GRANITE
SIZE: 9.845" x 39.38"
DIRECTION: ASHLAR, SEE PLAN

CPT-2

MANUFACTURER: INTERFACE
STYLE: AERIAL FLYING COLOR, AE315
COLOR: 105816 GRANITE / AZURE
SIZE: 9.845" x 39.38"
DIRECTION: ASHLAR, SEE PLAN

CPT-3

MANUFACTURER: INTERFACE
STYLE: AERIAL FLYING COLOR, AE317
COLOR: 105829 AZURE
SIZE: 9.845" x 39.38"
DIRECTION: ASHLAR, SEE PLAN

2 WALL TILE LEGEND

L - A1.03 3/8" = 1'-0"

3 FINISH LEGEND

L - A1.03 3/8" = 1'-0"

TACKarchitects

2922 N. 61st Street, Studio 1
Omaha, Nebraska 68104

402-505-9778
www.tackarch.com

OPS READING RECOVERY ROOMS - PROJECT 2
LIBERTY ELEMENTARY

Project Number: 2022.058.00
Date: 02/16/2024
Sheet Name: LIBERTY - FINISH MATERIALS

LIBERTY ELEMENTARY

L - A1.03

ELECTRICAL SYMBOLS			
SYMBOL	DESCRIPTION	SYMBOL	DESCRIPTION
POWER			
	DUPLEX RECEPTACLE		CEILING MOUNTED DOUBLE DUPLEX RECEPTACLE
G	"G" DENOTES GFCI TYPE		FLOOR BOX - COMBINATION POWER & DATA
>	">" DENOTES ISOLATED GROUND TYPE		POKE-THRU - COMBINATION POWER & DATA
H	"H" DENOTES HOSPITAL GRADE TYPE		FLOOR MOUNTED DUPLEX RECEPTACLE
TR	"TR" DENOTES TAMPER RESISTANT TYPE	#	MOTOR ("#" DENOTES HORSEPOWER RATING)
U	"U" DENOTES UNIVERSAL SERIAL BUS (USB) TYPE		DISCONNECT SWITCH
	DOUBLE SHADING DENOTES RED DEVICE	TE	THERMAL ELEMENT SWITCH
	SINGLE SHADING DENOTES SPLIT WIRED DEVICE		SWITCH & FUSE
	HORIZONTAL MOUNTED DUPLEX RECEPTACLE		SWITCH & FUSTAT
	CEILING MOUNTED DUPLEX RECEPTACLE		MAGNETIC MOTOR STARTER
	DOUBLE DUPLEX RECEPTACLE		COMBINATION MAGNETIC STARTER/DISCONNECT
	SINGLE RECEPTACLE		MOTOR CONTROL PUSHBUTTON STATION
	DRYER RECEPTACLE NEMA 14-30 (125/250V 30A)	R	RELAY
	RANGE RECEPTACLE NEMA 14-50 (125/250V 50A)		MULTI-OUTLET ASSEMBLY - LENGTH AS INDICATED
W	"W" DENOTES WELDER RECEPTACLE NEMA 6-50 (250V 50A)		
	SPECIAL PURPOSE RECEPTACLE (NEMA CONFIG. AS NOTED)		
COMMUNICATION			
	WALL PHONE OUTLET	S	INTERCOM CEILING SPEAKER
	WALL COMMUNICATIONS DATA OUTLET	S	INTERCOM WALL SPEAKER
	CEILING COMMUNICATIONS DATA OUTLET	S	SOUND REINFORCEMENT WALL SPEAKER
WAP	CEILING WIRELESS ACCESS POINT OUTLET	S	SOUND REINFORCEMENT CEILING SPEAKER
TV	TELEVISION/VIDEO OUTLET		WALL MICROPHONE OUTLET
	WALL CLOCK		CEILING MICROPHONE OUTLET
V	VOLUME CONTROL	C	CALL-IN DEVICE
	BASKET CABLE TRAY		LADDER CABLE TRAY
AVR	AV RACK OUTLET		
GENERAL			
	LIGHTING PANEL	J	WALL MOUNTED JUNCTION BOX
	DISTRIBUTION PANEL SWITCHBOARD OR MOTOR CONTROL CENTER		JUNCTION BOX
	CABINET, ENCLOSURE, OR CONTROL PANEL, TYPE INDICATED ON PLANS		CONDUIT SEAL
	BRANCH CIRCUIT - EXPOSED		CIRCUIT DOWN
	BRANCH CIRCUIT CONCEALED IN CEILING OR WALL		CIRCUIT UP
	BRANCH CIRCUIT CONCEALED IN FLOOR		CONDUIT STUB-OUT
	BRANCH CIRCUIT - CLASS TWO WIRING		CIRCUIT BREAK
	HOMERUN TO PANEL (QUANTITY OF ARROWS INDICATES QUANTITY OF CIRCUITS)		BELL
	SPECIAL PURPOSE HOMERUN AS INDICATED		PUSH BUTTON
E-3	CONDUIT / CONDUIT SLEEVE (SIZE INDICATED ON PLANS)	B	BUZZER
WP	SUBSCRIPT "WP" APPLIED TO ANY SYMBOL INDICATES WEATHERPROOF NEMA TYPE 3R OR EQUIVALENT	T	THERMOSTAT
3R OR RT	SUBSCRIPT "3R" OR "RT" APPLIED TO ANY SYMBOL INDICATES WEATHERPROOF NEMA TYPE 3R OR EQUIVALENT	E	SUBSCRIPT "E" ADDED TO ANY SYMBOL INDICATES EXISTING
		R	SUBSCRIPT "R" ADDED TO ANY SYMBOL INDICATES RELOCATED
PD	SUBSCRIPT "PD" ADDED TO ANY FLOOR OUTLET INDICATES PEDESTAL MOUNTED	(TYP)	WHERE (TYP) IS USED ON PLANS INDICATES A TYPICAL NOTE OR CONDITION
		DL	SUBSCRIPT "DL" ADDED TO ANY SYMBOL INDICATES DAMP LOCATION
EP	SUBSCRIPT "EP" APPLIED TO ANY SYMBOL INDICATES EXPLOSION PROOF CLASS, GROUP & DIVISION AS NOTED	K	SUBSCRIPT "K" ADDED TO ANY SYMBOL INDICATES KEY OPERATED
		P	SUBSCRIPT "P" ADDED TO ANY SYMBOL INDICATES PILOT LIGHT

- GENERAL AUDIO VISUAL NOTES:**
- AUDIO VISUAL ROUGH-INS PROVIDED BY ELECTRICAL CONTRACTOR.
 - PROVIDE J-HOOK CABLE SUPPORTS FOR ALL CABLE NOT SUPPORTED BY CABLE TRAY, MAXIMUM SPACING SHALL BE 60".
 - PROVIDE UL LISTED FIRESTOP AND SMOKESTOP ASSEMBLIES FOR ALL RATED PENETRATIONS.
 - PROVIDE 10' SERVICE LOOP FOR ALL COMMUNICATIONS CABLES AT COMMUNICATION TERMINATION ROOM, 3' SERVICE LOOP AT STATION END.
 - ALL TELECOMMUNICATIONS CABLING SHALL BE TERMINATED TO THE COMMUNICATIONS TERMINATION ROOM DESIGNATED FOR THAT SPECIFIC AREA OF THE FACILITY, UNLESS OTHERWISE INDICATED.
 - PROVIDE (2) 1-1/2"C. SLEEVES ABOVE ACCESSIBLE CEILING FROM EACH ROOM THROUGH WALL TO ABOVE NEAREST ACCESSIBLE CORRIDOR CEILING OR OVERHEAD PATHWAY. PROVIDE INSULATED BUSHINGS ON EACH END. SEAL BOTH ENDS OF CONDUIT WITH REMOVABLE PLENUM RATED ACOUSTICAL SEALANT.
 - PROVIDE DEVICES FOR A COMPLETE AND OPERATIONAL SYSTEM, INCLUDING ALL CABLES WITH TERMINATONS AS REQUIRED BY HARDWARE SHOWN. VERIFY FINAL QUANTITIES OF DEVICES.
 - CONTRATOR SHALL PROVIDE OWNER TRAINING ONCE PROGRAMMING, COMMISSIONING, AND SETUP OF SYSTEM IS COMPLETE. REFER TO SPECIFICATIONS FOR TRAINING REQUIREMENTS.
 - ALL PROGRAMMING CODE(S) FOR OWNER FURNISHED iPad SHALL BE TURNED OVER TO OWNER ONCE PROGRAMMING, COMMISSIONING, AND SETUP OF SYSTEM IS COMPLETE.
 - COORDINATE GRAPHIC USER INTERFACE TEMPLATE WITH OWNER FOR OWNER FURNISHED iPad.

MEI PROJECT #:21099


morrissey
engineeringinc

mechanical | electrical | lighting | technology | commissioning

4940 North 118th Street
Omaha, NE 68164

P: 402.491.4144
www.morrisseyengineering.com

ALL STRUCTURED CABLING IN RENOVATED AREA
TERMINATE IN NEAREST IT ROOM. PROVIDE ADDITIONAL
PATCH PANELS TO MATCH EXISTING TO ACCOMMODATE
NEW DATA CABLING. COORDINATE TERMINATION
LOCATION WITH IT PERSONNEL PRIOR TO INSTALLATION.

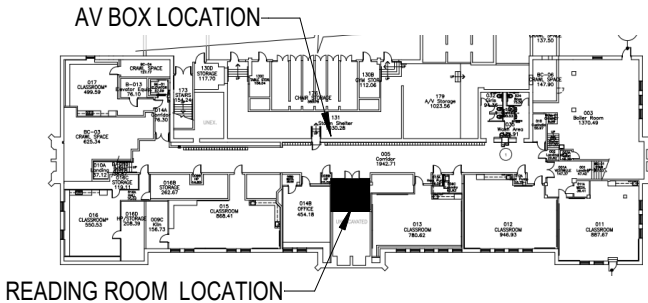


1 CASTELAR KEY PLAN
1" = 100'-0"

GENERAL NOTES:

1. SEE ELECTRICAL COVER SHEET E0.0 FOR ELECTRICAL GENERAL NOTES.

KEYNOTES

- AV101 PROVIDE RECEPTACLE AND LOW VOLTAGE ROUGH IN FOR CEILING AV BOX. PROVIDE 1-1/2"C. WITH PULL STRING FROM LOW VOLTAGE ROUGH IN TO LOCATION INDICATED ON PLAN. COORDINATE EXACT LOCATION AND ADDITIONAL ROUGH IN REQUIREMENTS WITH GENERAL CONTRACTOR, OWNER AND EQUIPMENT MANUFACTURER PRIOR TO ROUGH-IN.
- AV102 PROVIDE 2-GANG DEEP JUNCTION BOX WITH SINGLE GANG RING AND 1"C. TO ABOVE ACCESSIBLE CEILING.
- AV103 CONNECT TO NEW (20/1) BREAKER IN NEAREST 120/208 ELECTRICAL PANEL. IF NO AVAILABLE SPACES EXISTING COMBINE LIGHTLY LOADED CIRCUITS WITH SAME PROPERTIES AS REQUIRED TO ACCOMMODATE REMODEL.
- AV104 PROVIDE QUANTITY OF DATA CABLES INDICATED AT EACH ROUGH-IN LOCATION.

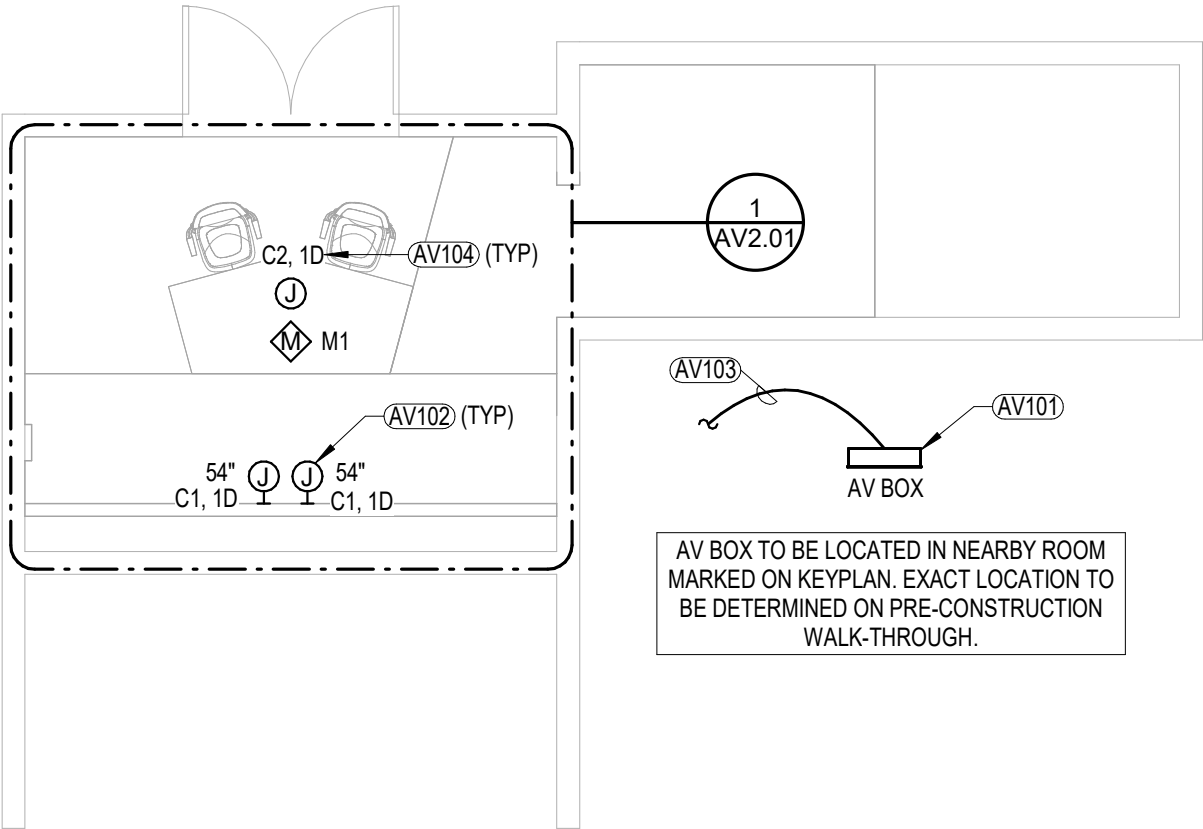

2 CASTELAR READNG ROOM
3/16" = 1'-0"

MEI PROJECT #:21099

**morrissey
engineering**inc

mechanical | electrical | lighting | technology | commissioning

4940 North 118th Street
Omaha, NE 68164

P: 402.491.4144
www.morrisseyengineering.com

TACKarchitects
2922 N. 61st Street, Studio 1
Omaha, Nebraska 68104


402-505-9778
www.tackarch.com

OPS READING RECOVERY ROOMS - PROJECT 2
CASTELAR ELEMENTARY

Project Number:
Date: 02/16/2024
Sheet Name: CASTELAR ELEMENTARY - AUDIO VISUAL PLAN

AV1.01

ALL STRUCTURED CABLING IN RENOVATED AREA
TERMINATE IN NEAREST IT ROOM. PROVIDE ADDITIONAL
PATCH PANELS TO MATCH EXISTING TO ACCOMMODATE
NEW DATA CABLING. COORDINATE TERMINATION
LOCATION WITH IT PERSONNEL PRIOR TO INSTALLATION.

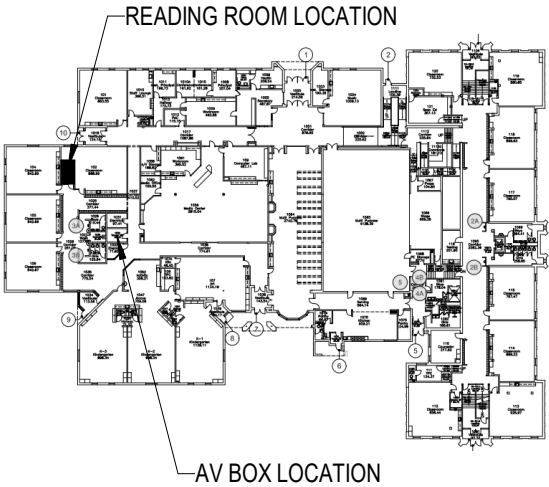

2 CENTRAL PARK KEY PLAN
1" = 100'-0"

 
GENERAL NOTES:

1. SEE ELECTRICAL COVER SHEET E0.0 FOR ELECTRICAL GENERAL NOTES.

KEYNOTES

- AV101 PROVIDE RECEPTACLE AND LOW VOLTAGE ROUGH IN FOR CEILING AV BOX. PROVIDE 1-1/2"C. WITH PULL STRING FROM LOW VOLTAGE ROUGH IN TO LOCATION INDICATED ON PLAN. COORDINATE EXACT LOCATION AND ADDITIONAL ROUGH IN REQUIREMENTS WITH GENERAL CONTRACTOR, OWNER AND EQUIPMENT MANUFACTURER PRIOR TO ROUGH-IN.
- AV102 PROVIDE 2-GANG DEEP JUNCTION BOX WITH SINGLE GANG RING AND 1"C. TO ABOVE ACCESSIBLE CEILING.
- AV103 CONNECT TO NEW (20/1) BREAKER IN NEAREST 120/208 ELECTRICAL PANEL. IF NO AVAILABLE SPACES EXISTING COMBINE LIGHTLY LOADED CIRCUITS WITH SAME PROPERTIES AS REQUIRED TO ACCOMMODATE REMODEL.
- AV104 PROVIDE QUANTITY OF DATA CABLES INDICATED AT EACH ROUGH-IN LOCATION.

MEI PROJECT #:21099




**morrissey
engineering inc**

mechanical | electrical | lighting | technology | commissioning

4940 North 118th Street
Omaha, NE 68164

P: 402.491.4144

www.morrisseyengineering.com

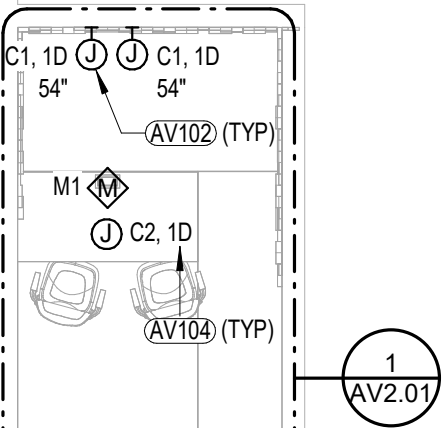

AV BOX TO BE LOCATED IN NEARBY ROOM
MARKED ON KEYPLAN. EXACT LOCATION TO
BE DETERMINED ON PRE-CONSTRUCTION
WALK-THROUGH.

1 CENTRAL PARK READING ROOM
3/16" = 1'-0"

TACKarchitects

2922 N. 61st Street, Studio 1
Omaha, Nebraska 68104


402-505-9778
www.tackarch.com

OPS READING RECOVERY ROOMS - PROJECT 2
CENTRAL PARK ELEMENTARY

Project Number:
Date: 02/16/2024
Sheet Name: CENTRAL PARK ELEMENTARY - AUDIO VISUAL PLAN

AV1.02

ALL STRUCTURED CABLING IN RENOVATED AREA
TERMINATE IN NEAREST IT ROOM. PROVIDE ADDITIONAL
PATCH PANELS TO MATCH EXISTING TO ACCOMMODATE
NEW DATA CABLING. COORDINATE TERMINATION
LOCATION WITH IT PERSONNEL PRIOR TO INSTALLATION.

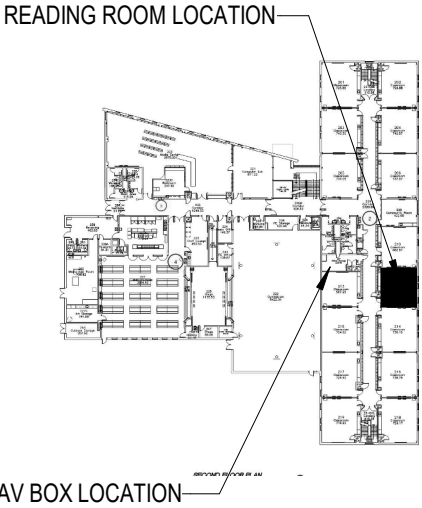

2 LIBERTY KEY PLAN
1" = 100'-0"

GENERAL NOTES:

1. SEE ELECTRICAL COVER SHEET E0.0 FOR ELECTRICAL GENERAL NOTES.

KEYNOTES

- AV101 PROVIDE RECEPTACLE AND LOW VOLTAGE ROUGH IN FOR CEILING AV BOX. PROVIDE 1-1/2"C. WITH PULL STRING FROM LOW VOLTAGE ROUGH IN TO LOCATION INDICATED ON PLAN. COORDINATE EXACT LOCATION AND ADDITIONAL ROUGH IN REQUIREMENTS WITH GENERAL CONTRACTOR, OWNER AND EQUIPMENT MANUFACTURER PRIOR TO ROUGH-IN.
- AV102 PROVIDE 2-GANG DEEP JUNCTION BOX WITH SINGLE GANG RING AND 1"C. TO ABOVE ACCESSIBLE CEILING.
- AV103 CONNECT TO NEW (20/1) BREAKER IN NEAREST 120/208 ELECTRICAL PANEL. IF NO AVAILABLE SPACES EXISTING COMBINE LIGHTLY LOADED CIRCUITS WITH SAME PROPERTIES AS REQUIRED TO ACCOMMODATE REMODEL.
- AV104 PROVIDE QUANTITY OF DATA CABLES INDICATED AT EACH ROUGH-IN LOCATION.

MEI PROJECT #:21099

**morrissey
engineering inc**

mechanical | electrical | lighting | technology | commissioning

4940 North 118th Street
Omaha, NE 68164

P: 402.491.4144
www.morrisseyengineering.com

TACKarchitects

2922 N. 61st Street, Studio 1
Omaha, Nebraska 68104


402-505-9778
www.tackarch.com

OPS READING RECOVERY ROOMS - PROJECT 2
LIBERTY ELEMENTARY

Project Number:
Date: 02/16/2024
Sheet Name: LIBERTY ELEMENTARY - AUDIO VISUAL PLAN

AV1.03

AV BOX TO BE LOCATED IN NEARBY ROOM
MARKED ON KEYPLAN. EXACT LOCATION TO
BE DETERMINED ON PRE-CONSTRUCTION
WALK-THROUGH.

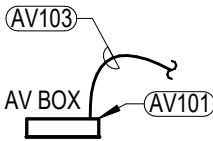

AV104 (TYP)

C2, 1D

J


M1

J 108"
C1, 1D

1
AV2.01

108" AV102 (TYP)
J C1, 1D

1 LIBERTY READING ROOM
3/16" = 1'-0"

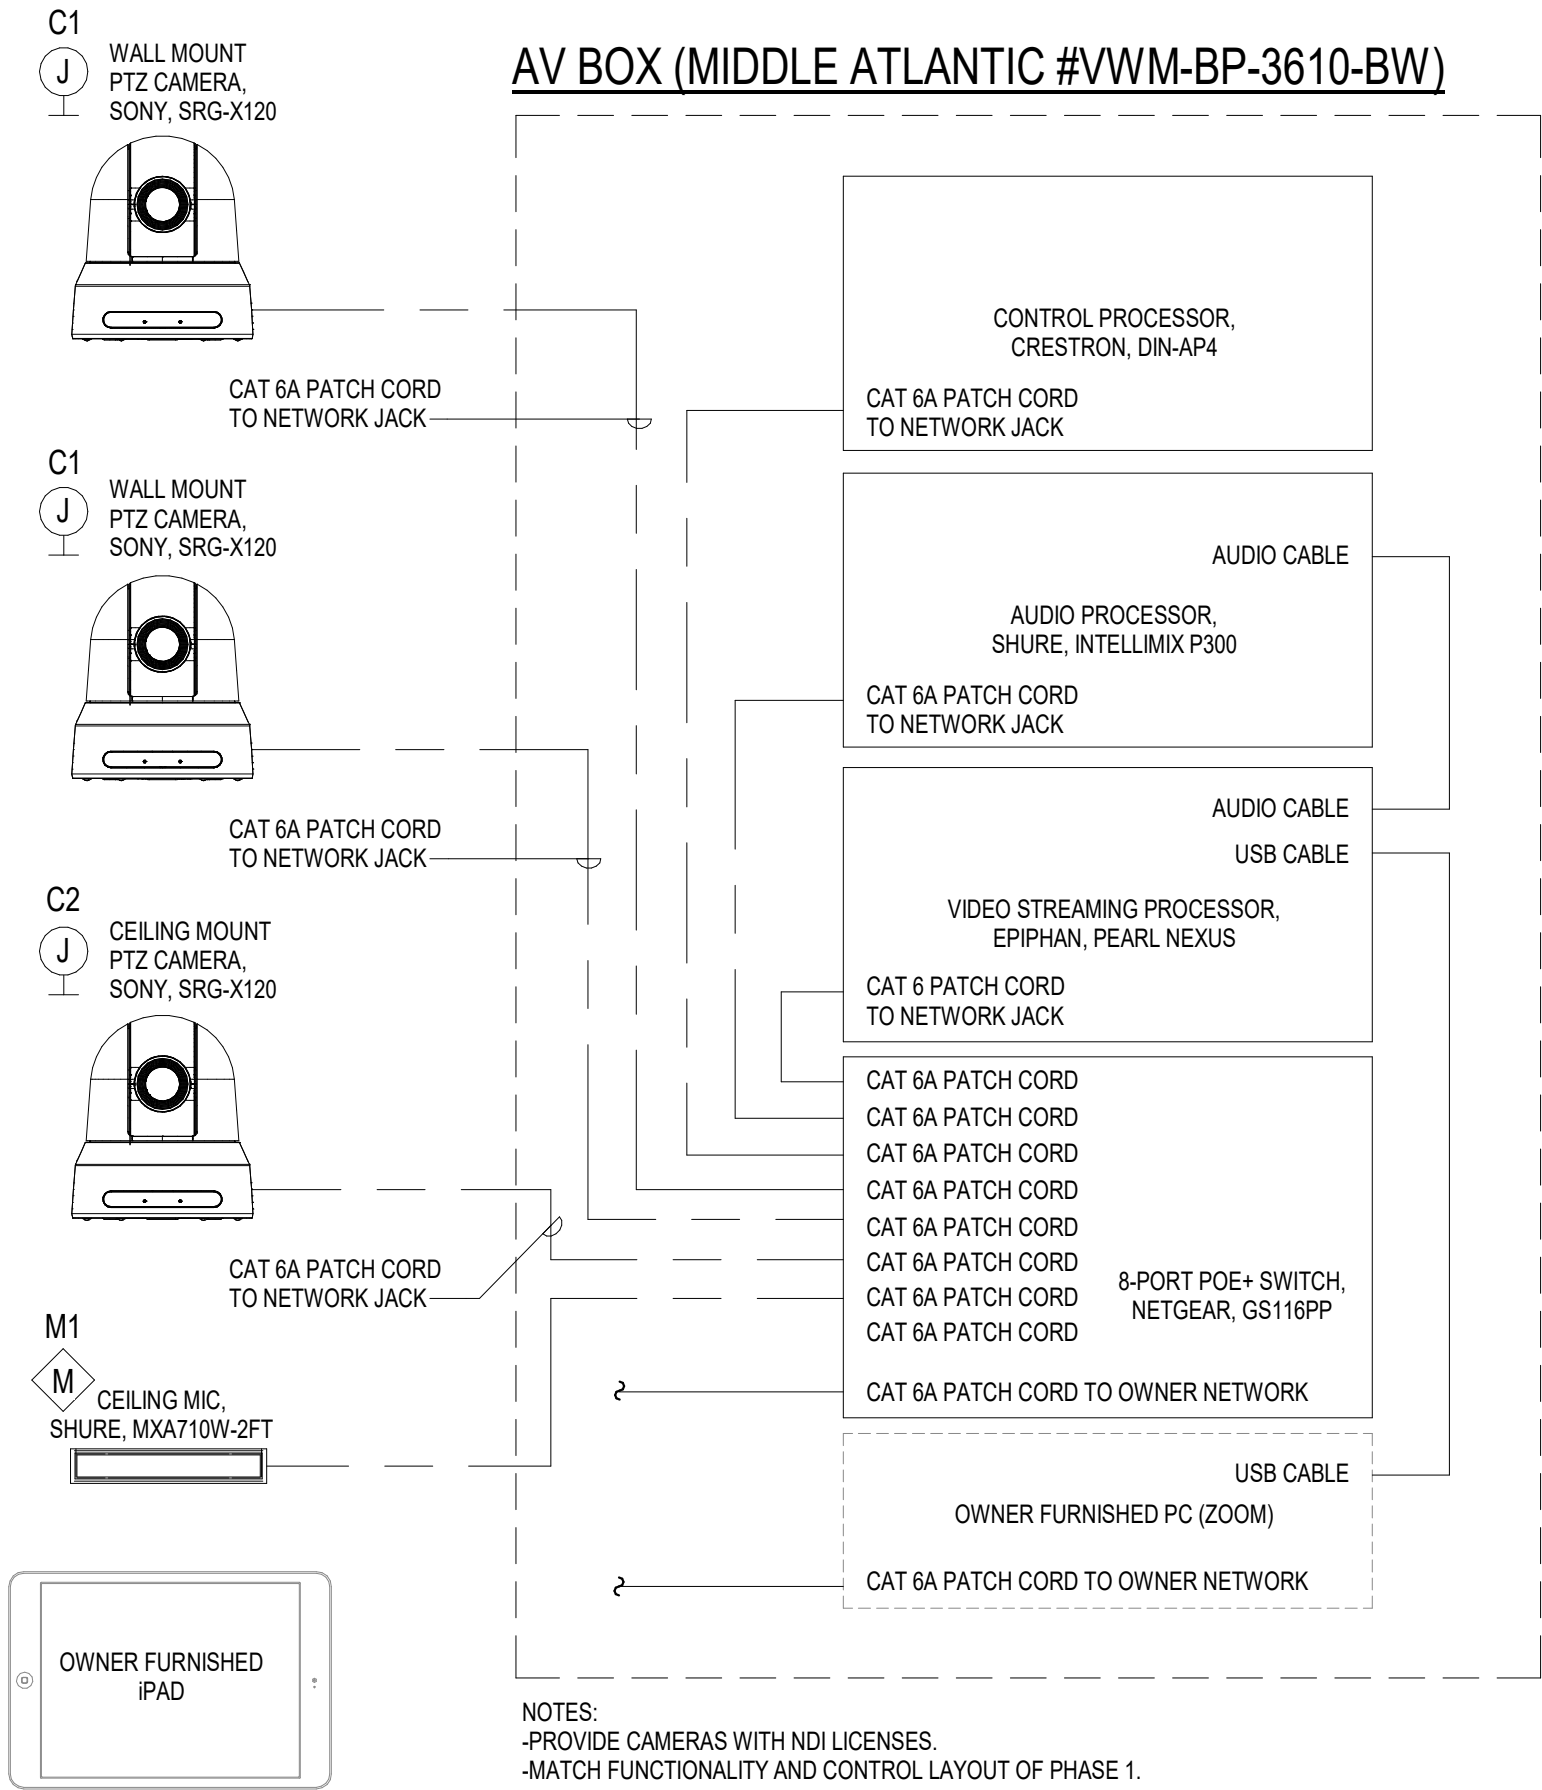

MEI PROJECT #:21099

morrissey engineering inc

mechanical | electrical | lighting | technology | commissioning

4940 North 118th Street
Omaha, NE 68164

P: 402.491.4144

www.morrisseyengineering.com